

2 projectors - mounted from ceiling
 prefer Epson brand
 ability to project in both units
 using one port/PC

connections for HDMI
 + VOA

Contractor responsible for all permits and fees.

2 - 120 V receptacles
 per plate


2 - data ports per plate

16 data plates / 32 total
 4 of which are
 moved from the column

18 power plates / 36 total

1 set of data
 + power moved from
 back wall to
 new wall

x data - Cat 6
 + power

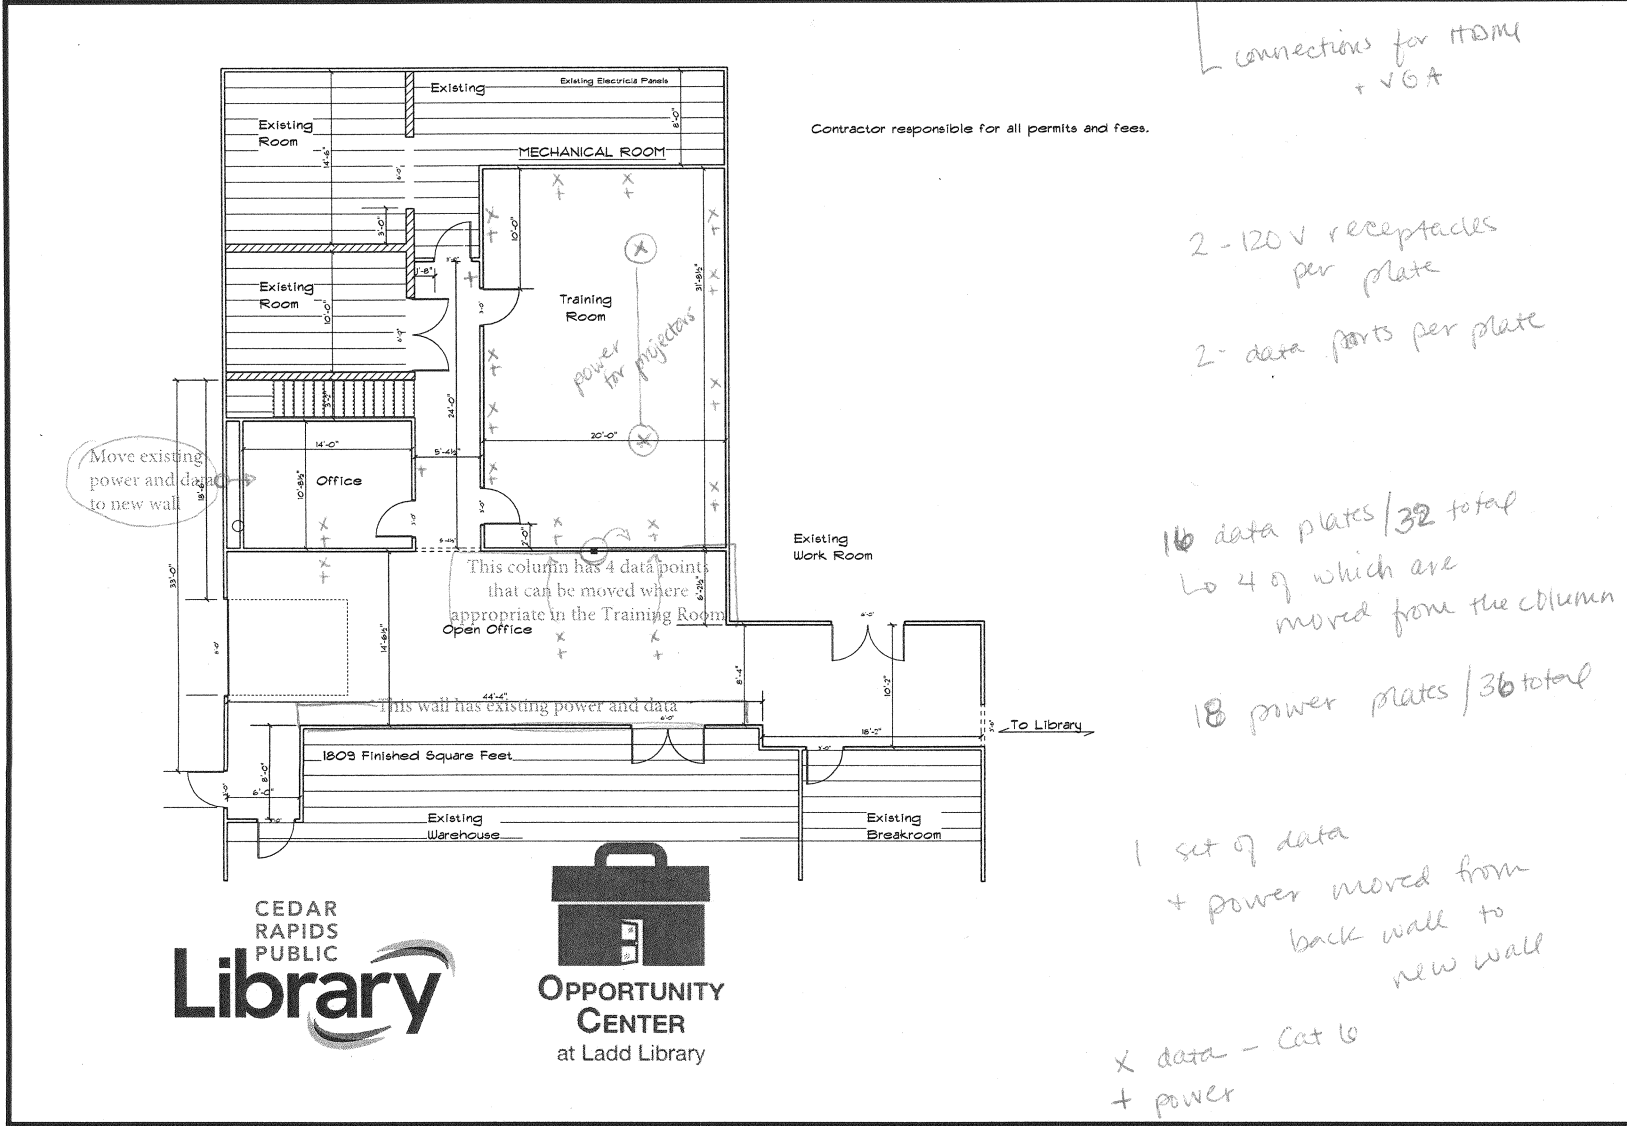

FLOOR PLAN	
DATE August 01, 2018	REVISED
DRAWING*	
SCALE	BDS
DRAWN BY	APPROVED
LADD LIBRARY OPPORTUNITY CENTER	

Image 1



Image 2

